




EAST ELEVATION

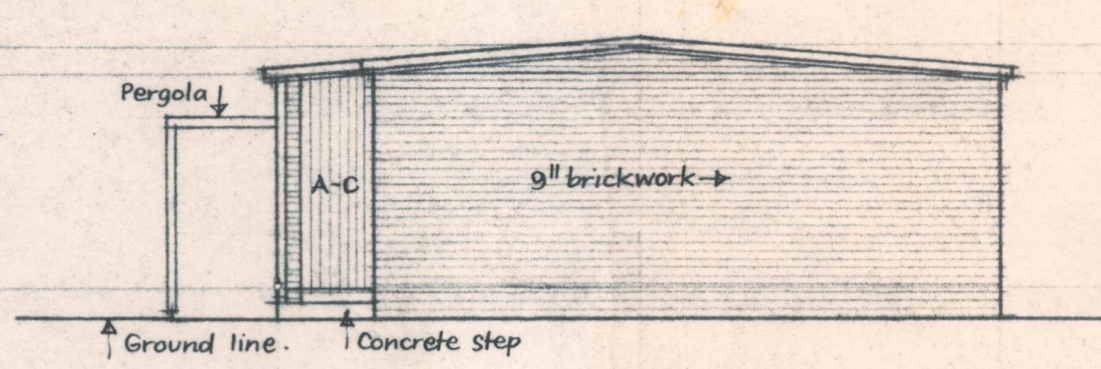


SOUTH ELEVATION

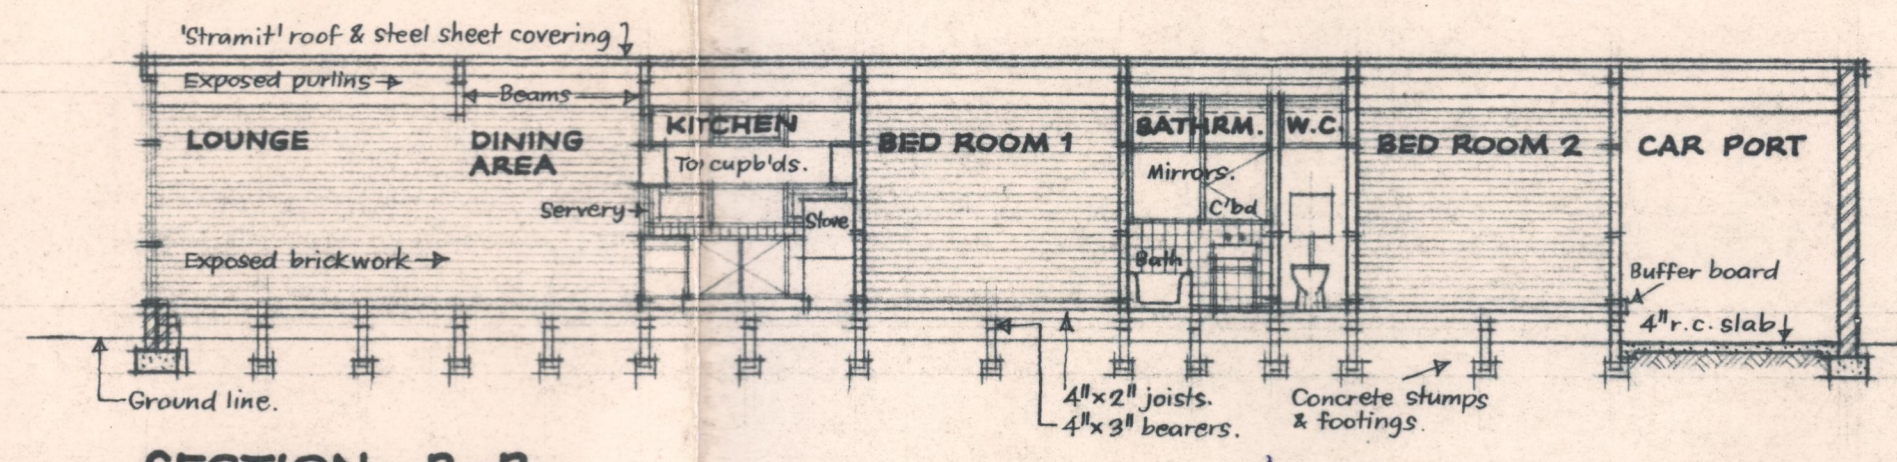


SECTION B-B

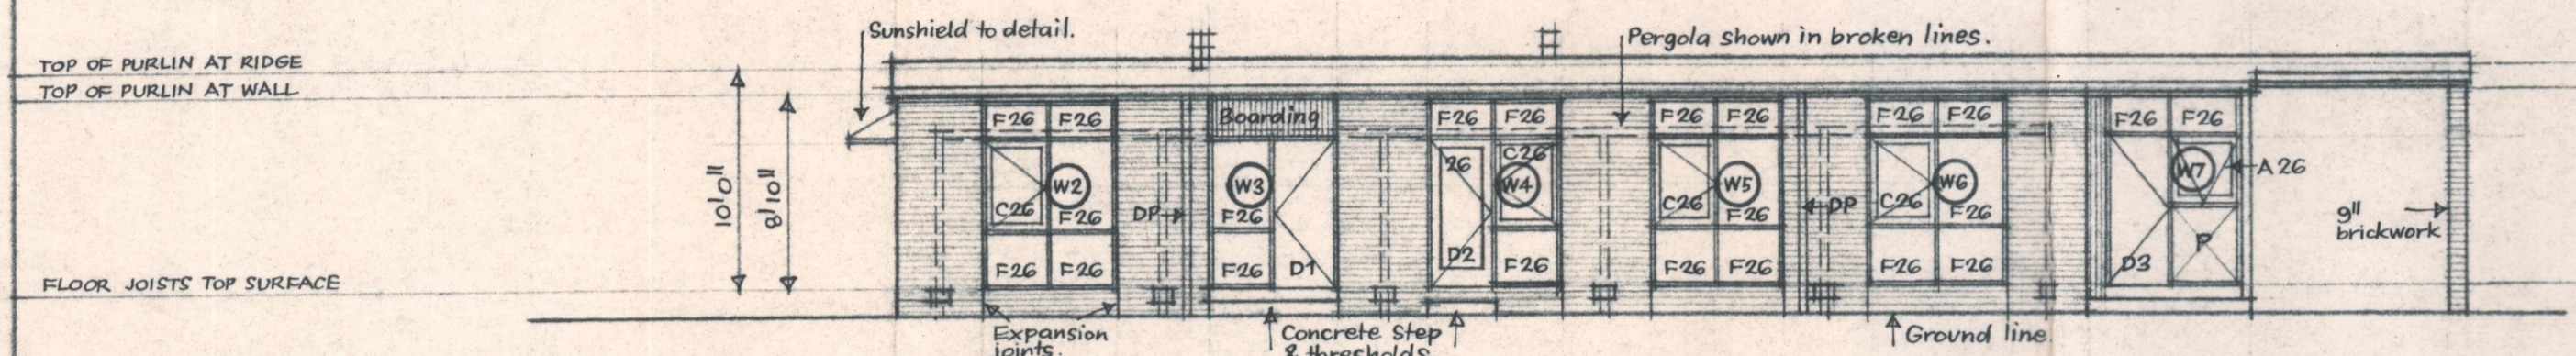

WEST ELEVATION

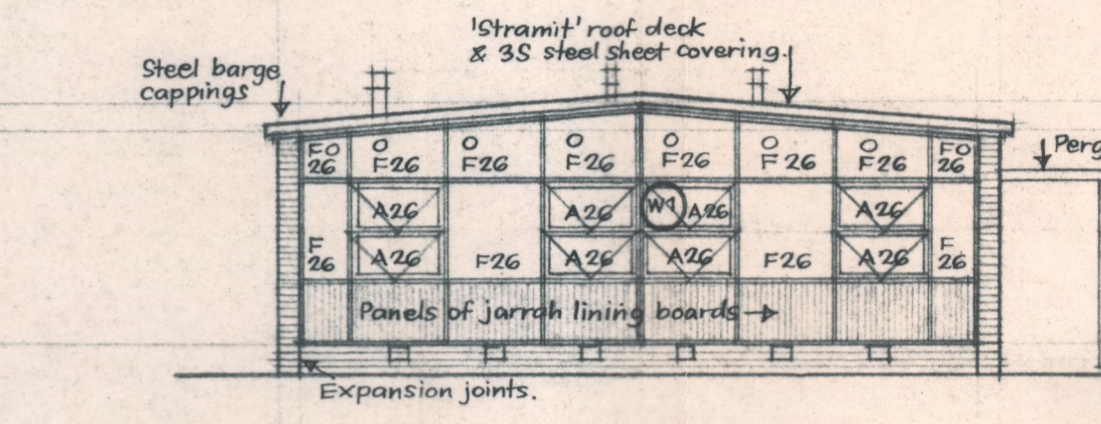

NORTH ELEVATION

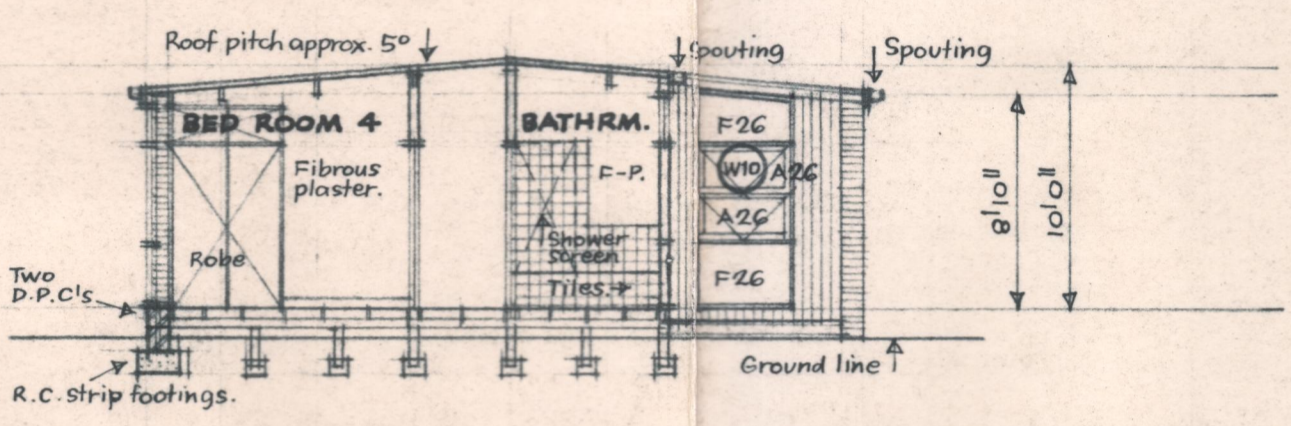

SECTION A-A


WINDOW & DOOR SYMBOLS

(W1) Window types. Refer to specification for schedule.
 (D2) Door types. Refer to specification for schedule.
 F Fixed glazing.
 A Awning type sash.
 C Casement type sash.
 V Fixed glazing with ventilator formed by an overlapping strip of glass.
 P Panel of tempered hardboard beaded in.
 2G 2G oz sheet glass.
 3Z 3Z oz ditto.
 O Obscure glass as selected.
 Refer also to specification.


SYMBOLS ON SITE PLAN

1 Sink.	7 Troughs.
2 Bath.	8 Urinal.
3 Shower.	9 W.C. pan.
4 Basin.	10 W.C. pan.
5 W.C. pan.	→ SP Stand pipe.
6 Washing machine.	≡ DP Downpipe.

--- New 4" diam. s.p.d. sewer line.
 --- New C.I.P. replacing 4" dia. s.p.d.
 --- Existing sewer drains to remain.
 --- Retention sewer in easement.
 --- New 4" diam. stormwater drain discharging into street channel.
 Levels shown are from M.M.B.W. drawings.

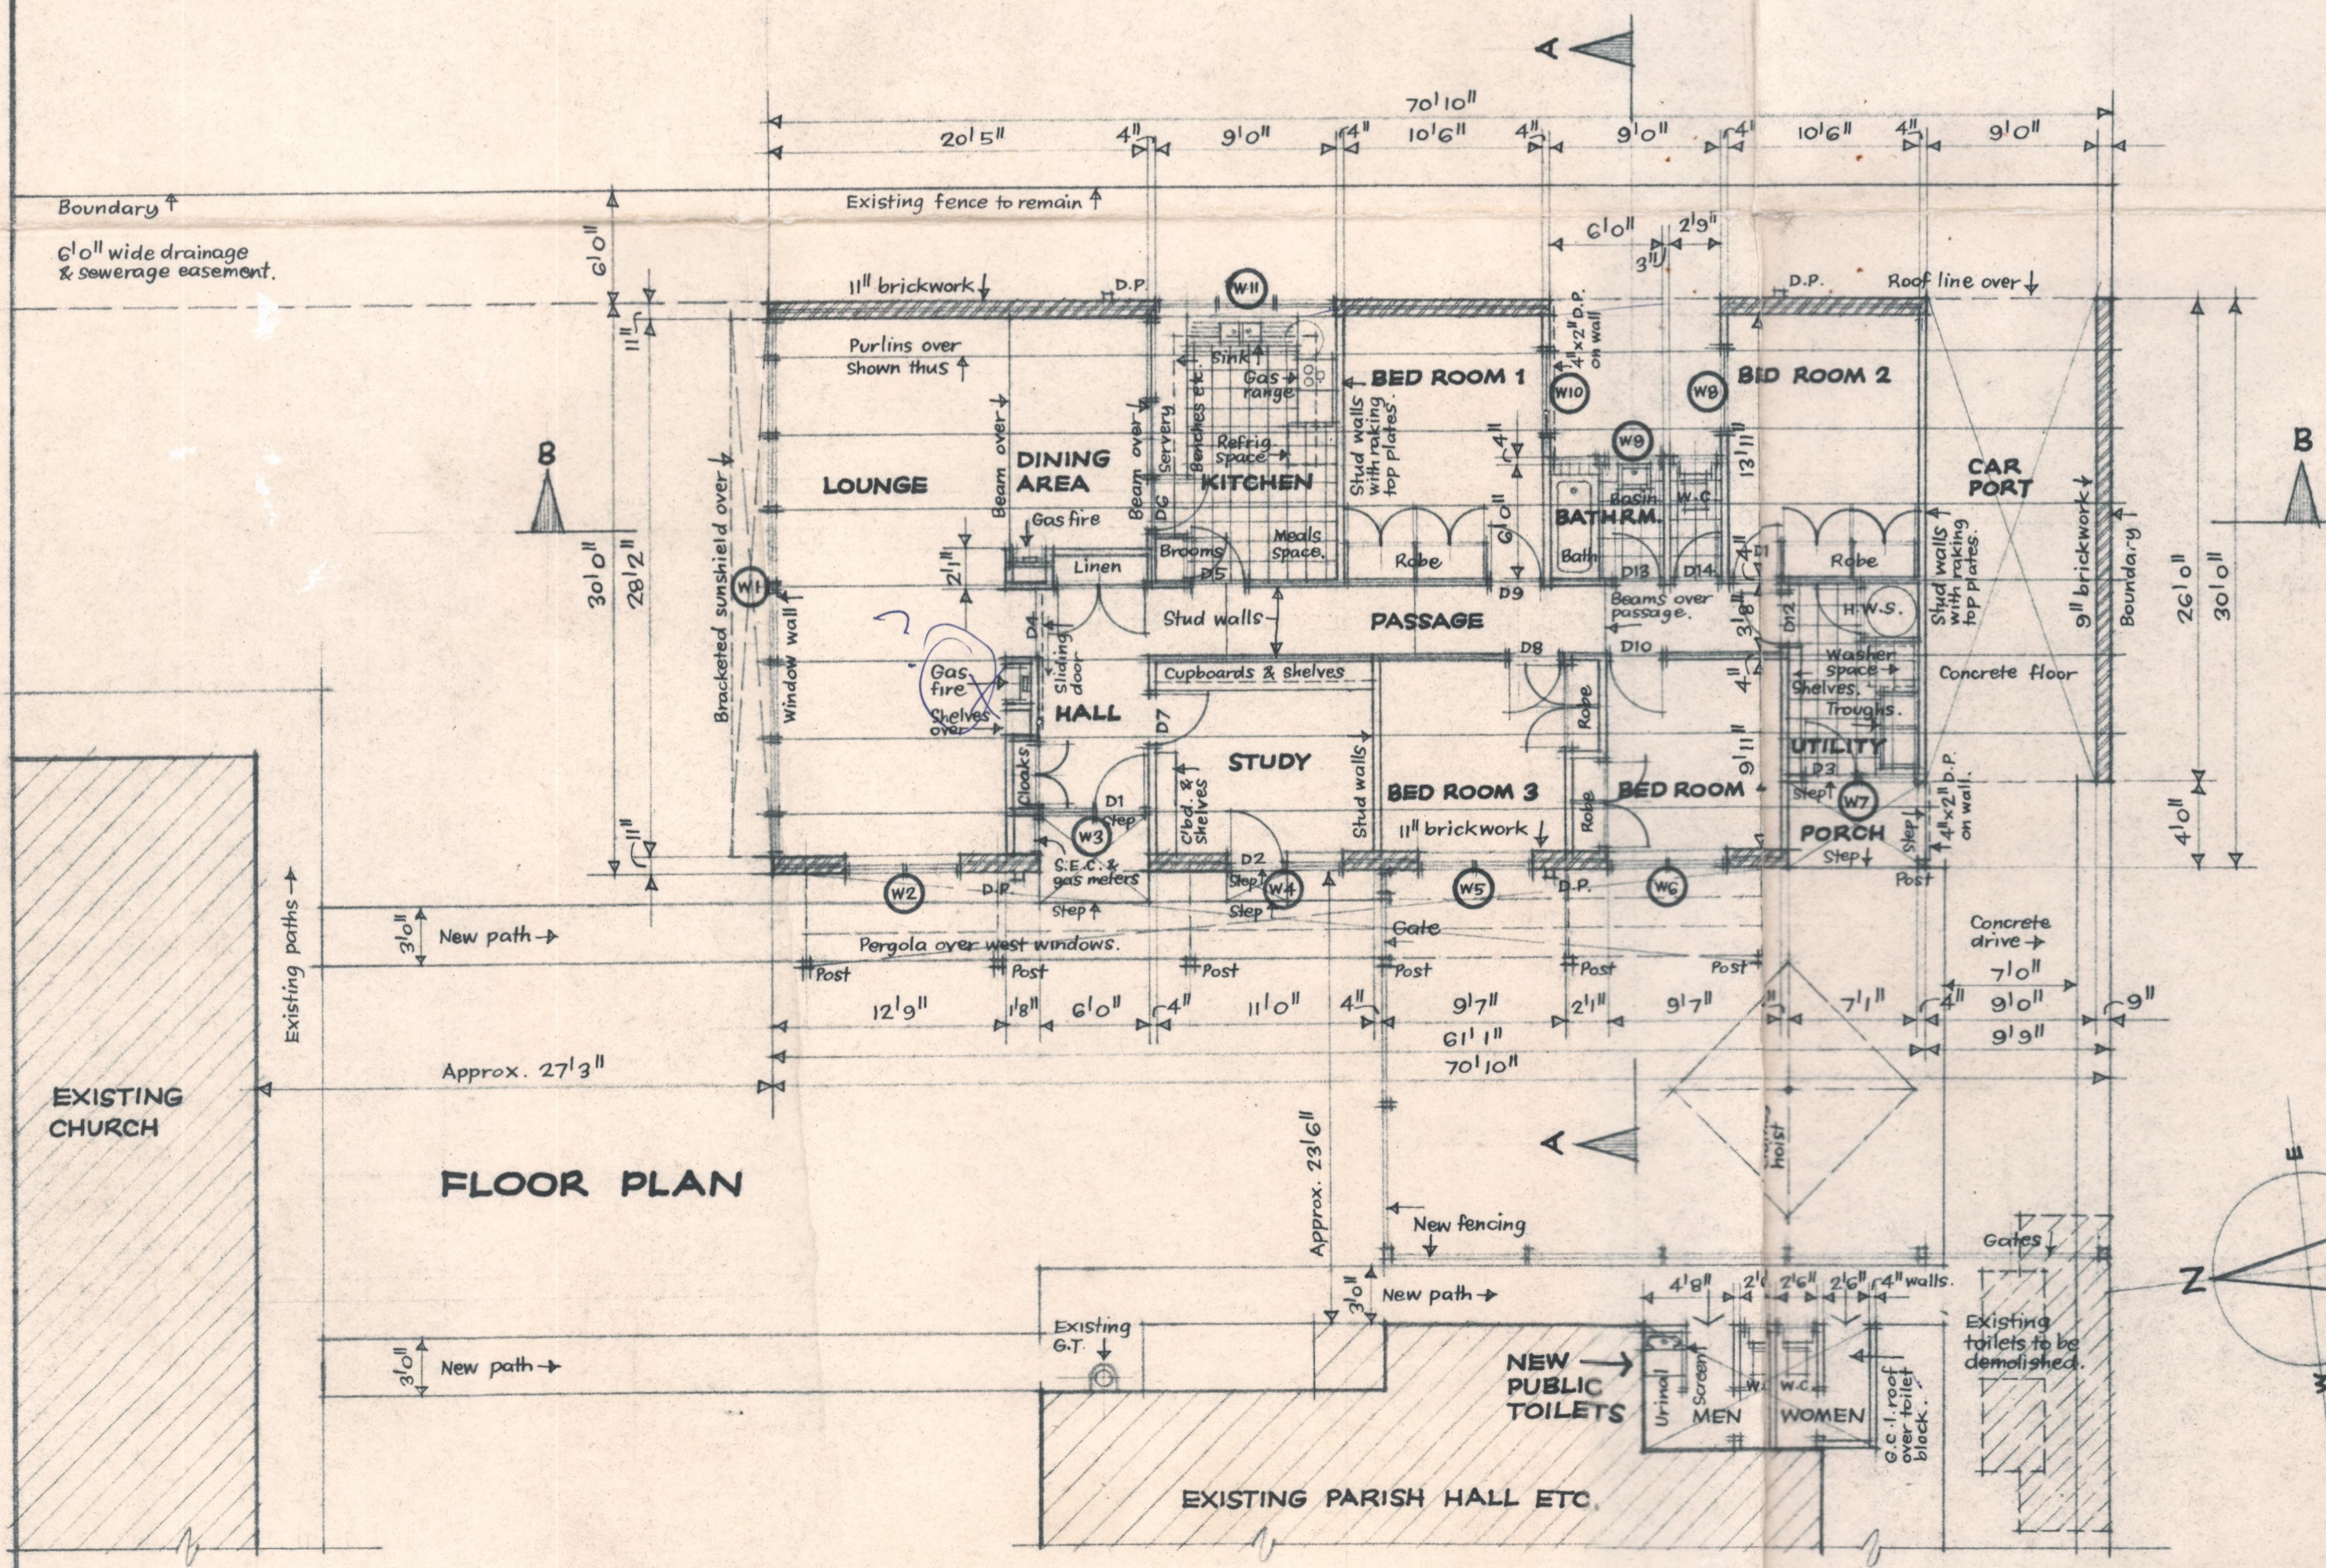

FLOOR PLAN

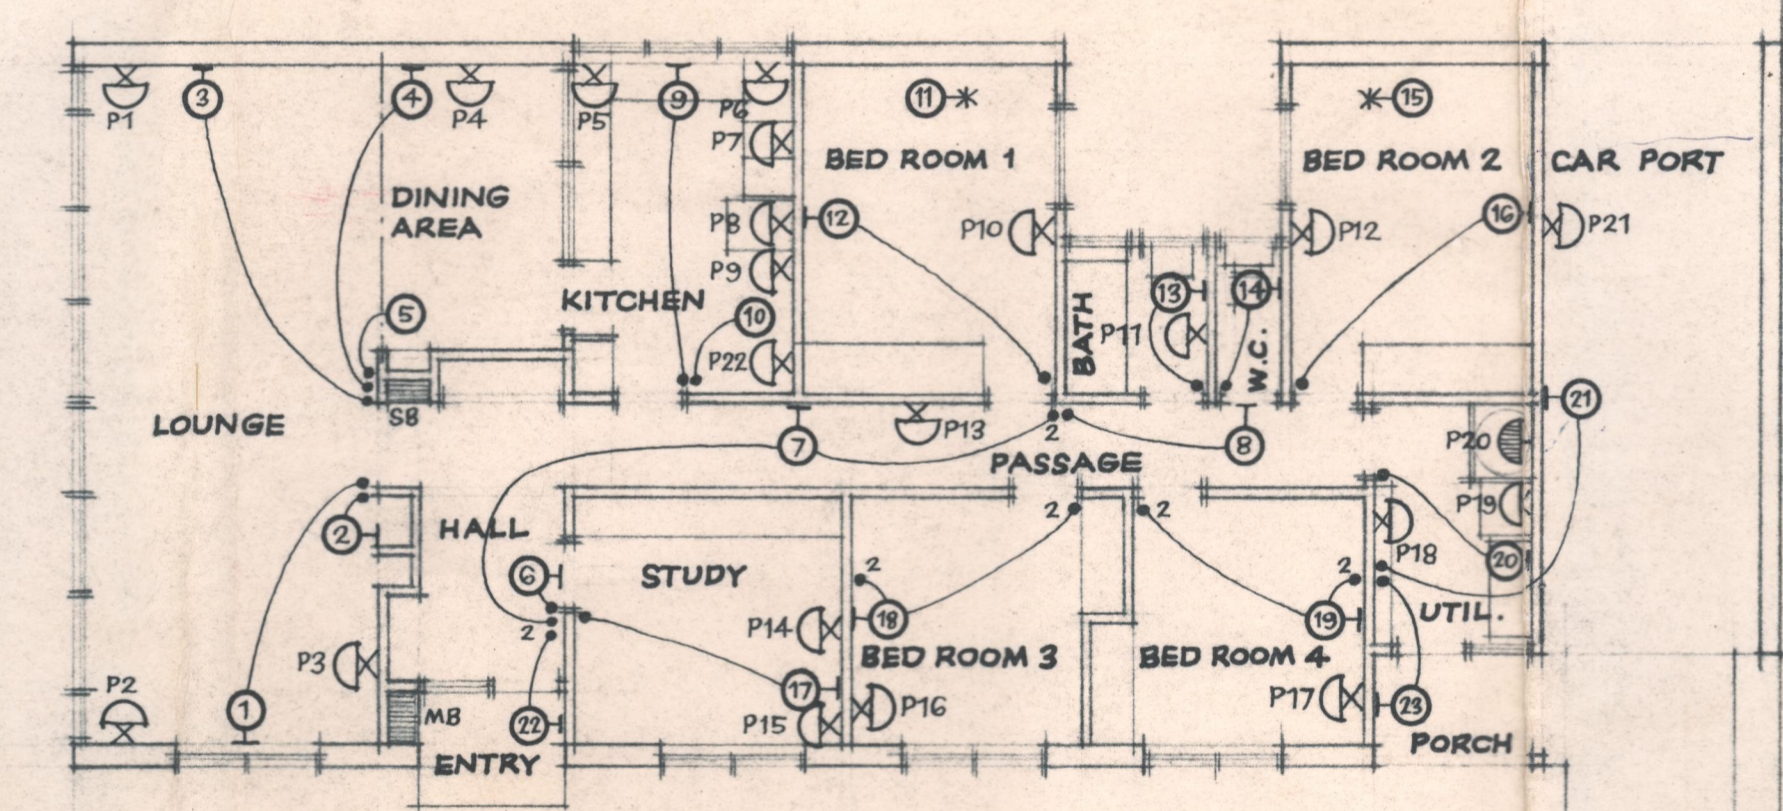


ELECTRICAL PLAN

ELECTRICAL SYMBOLS

(1) Wall bracket light outlet.
 (11) Ceiling light outlet.
 (P1) General purpose power outlet & switch.
 (P20) Directly connected power outlet.
 • Flush switch.
 2 • Ditto 2-way.
 * Ceiling pull-cord switch.
 (MB) Meter in wall recess.
 (SB) Switchboard in wall recess.

Wiring generally to be kept off ceilings.
 Refer to specification for details of light & power outlets.

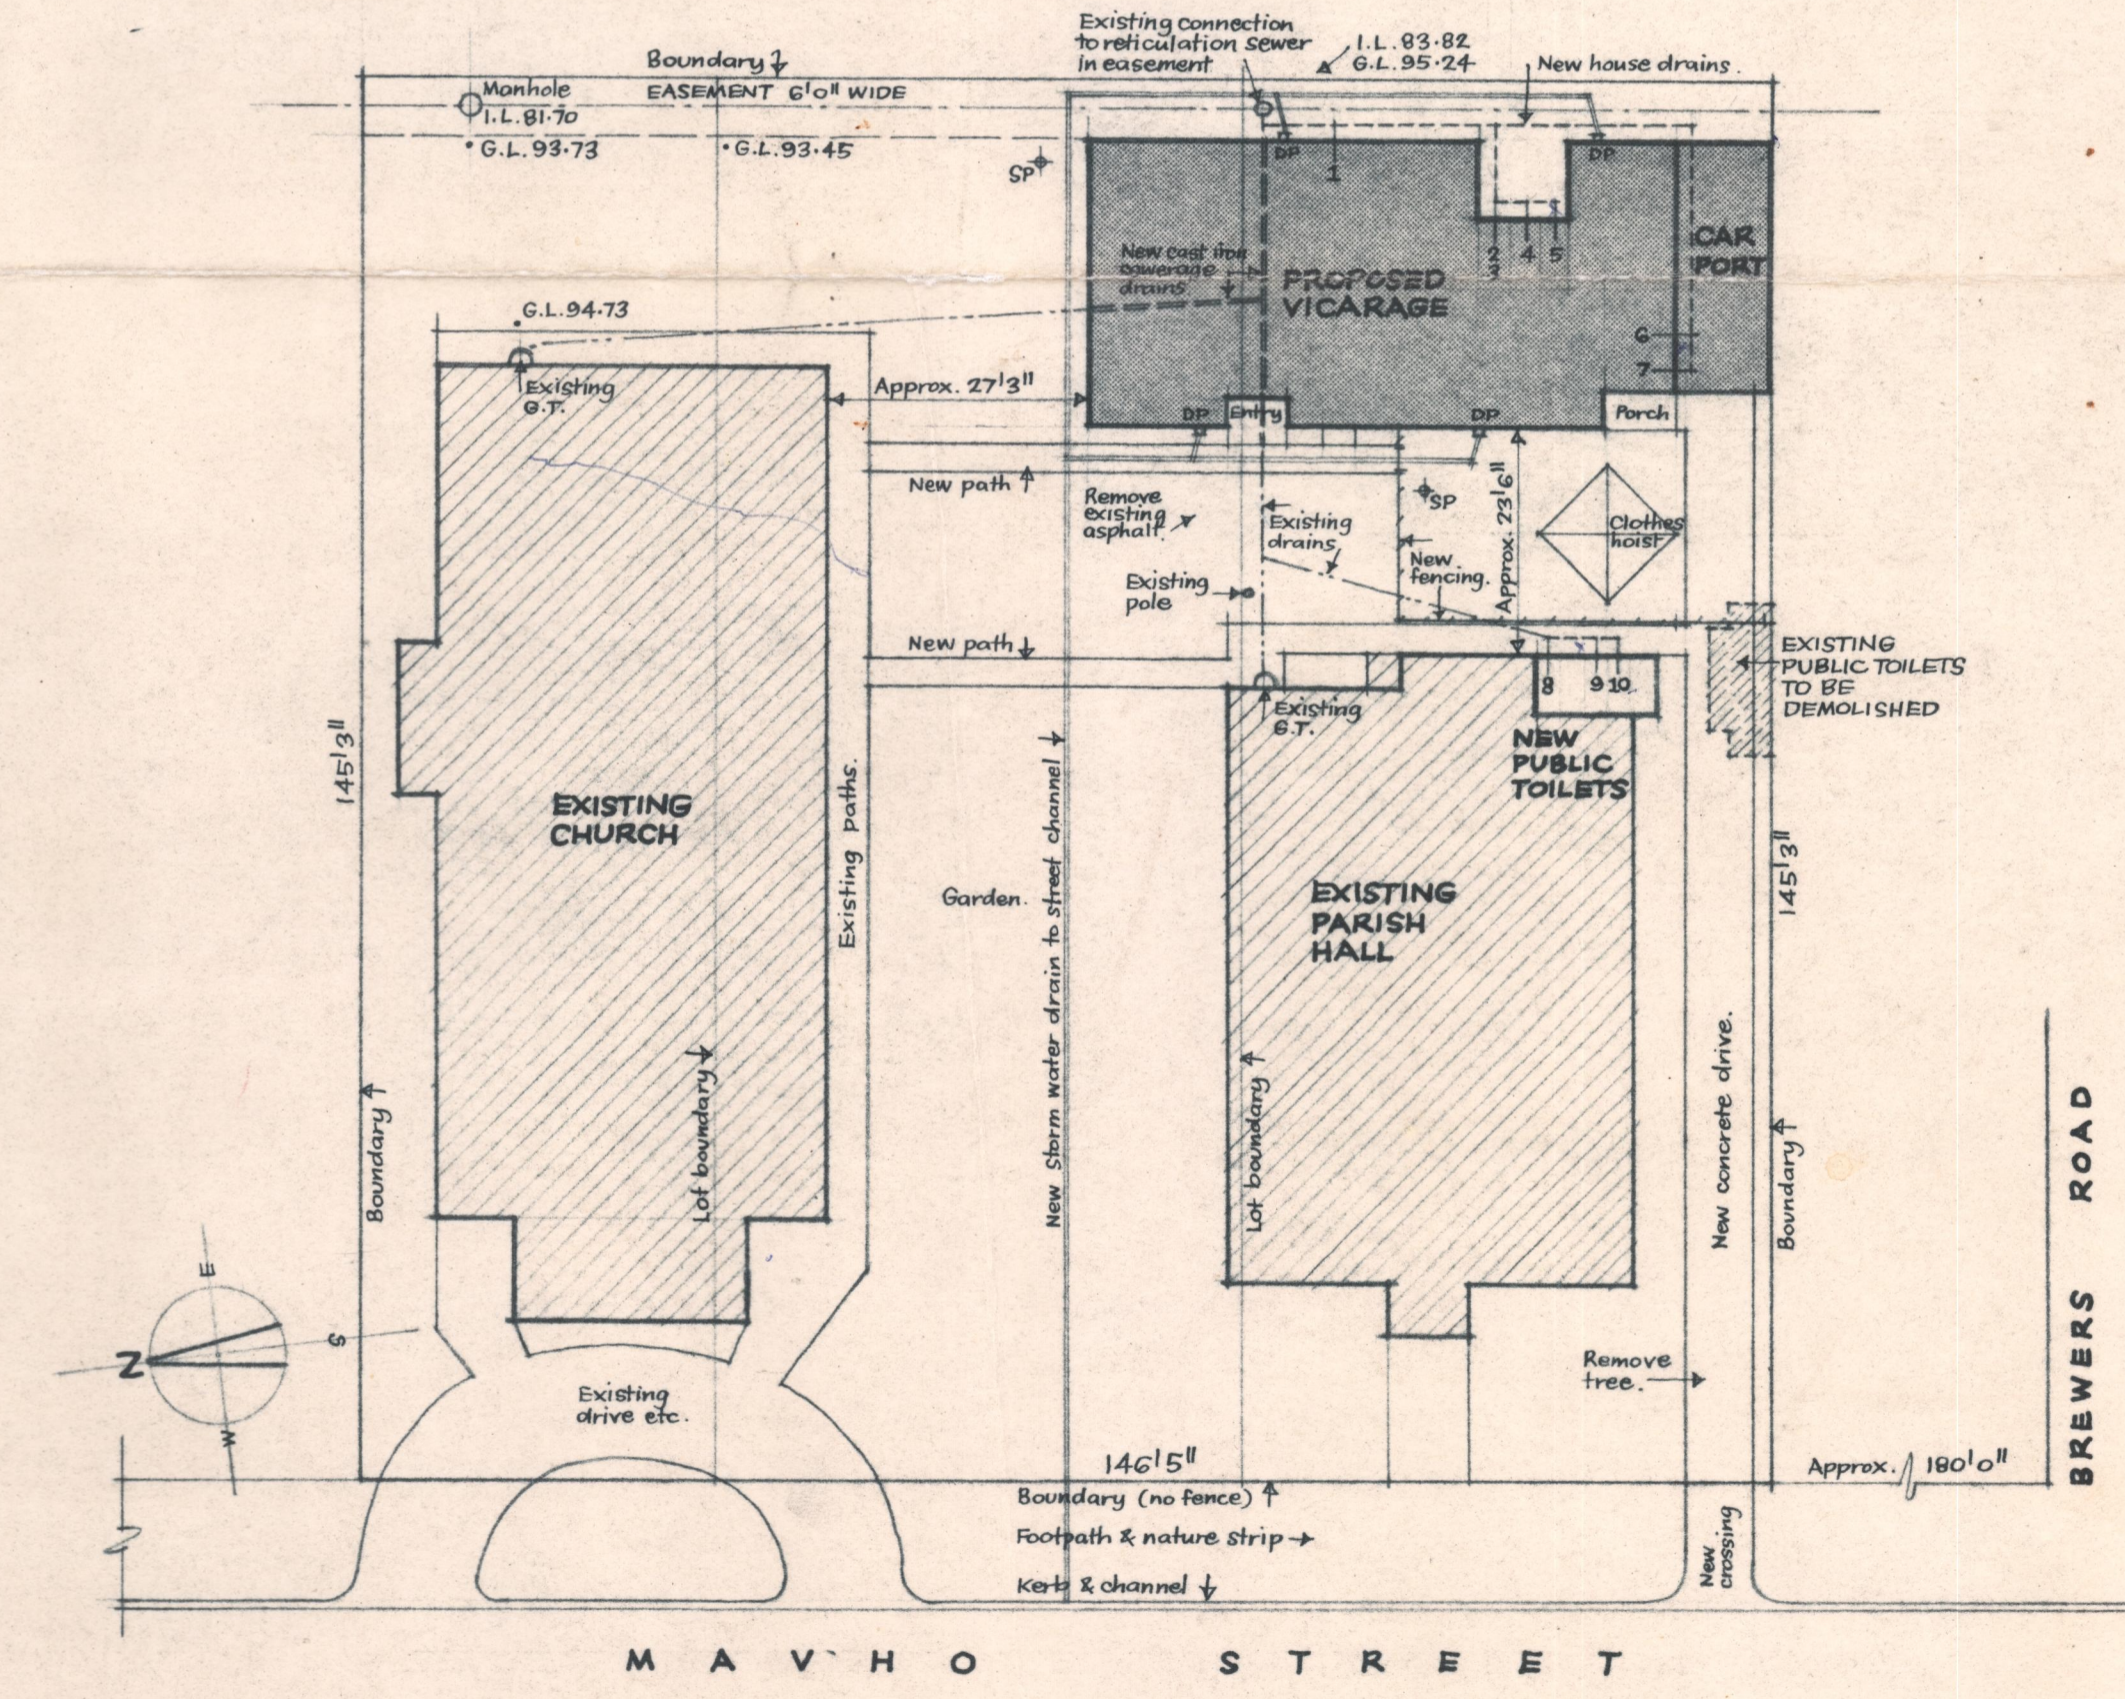


SITE PLAN

SCALE: 1" = 20' 0"
 M.M.B.W. particulars:
 Detail Plan No 3252 (amended copy)
 Drainage Plan No 159638
 Municipality of Moorbabin.

ST. GEORGE'S CHURCH OF ENGLAND, BENTLEIGH	JOB No. 5909	THE DESIGNERS PANEL
PROPOSED VICARAGE: WORKING DRAWING.	DRG. No. 10	28 WELLINGTON STREET, RICHMOND 48 5310
	SCALE 1" = 8' 0"	DATE 3 JUL 1959

St George's Vicarage
Working Drawings
13 July 1959

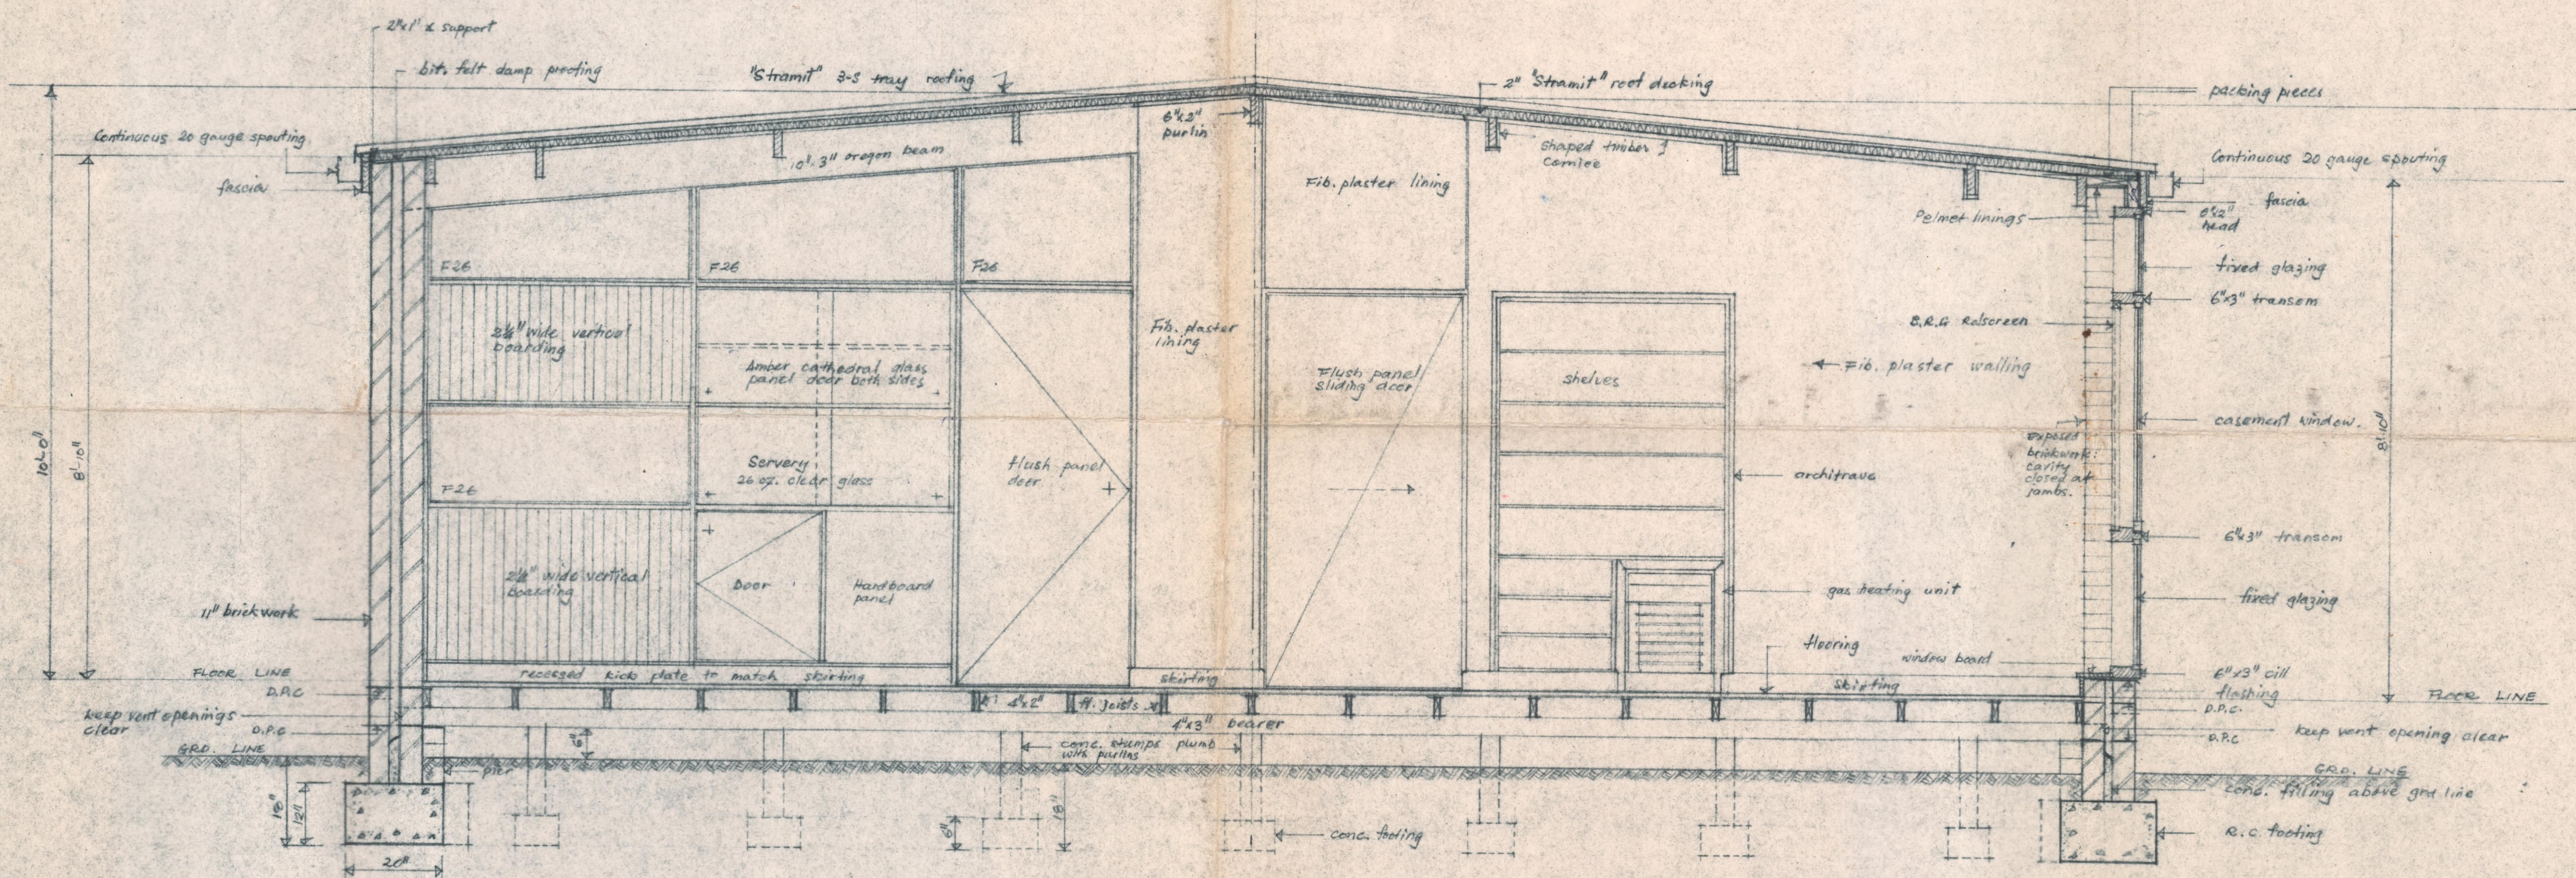

DETAILED SECTION THROUGH LOUNGE & DINING ROOM
LOOKING SOUTH

SYMBOLS:
 F FIXED GLAZING
 26 26 OZ. CLEAR SHEET GLASS

ST. GEORGE'S BENTLEIGH	JOB No. 5909	THE DESIGNERS PANEL
PROPOSED VICARAGE	DRG. No. 9	
DETAILED SECTION	SCALE 1/2" = 1'-0"	28 WELLINGTON STREET, RICHMOND 95 5810
	DATE 1 JUL 1959	

St George's Bantleigh
Proposed Vicarage
Detailed Section
Date 11 July 1959